

EQUIPMENT LOCATION LEGEND

- ▲ LOGIC CABINET
- ▲ LOGIC CABINET DOOR
- ① SPRAY MACHINE #1
- ② SPRAY MACHINE #2
- ③ SPRAY MACHINE #3
- ④ SPRAY MACHINE #4
- ⑤ SPRAY MACHINE #5
- ⑥ SPRAY MACHINE #6

DIP SWITCH SETTINGS FOR I/O CARDS

SLOT	SW1	SW2	SW3
SLOT 00	ON	ON	ON
SLOT 01	ON	ON	ON
SLOT 02	ON	ON	ON
SLOT 03	ON	ON	ON
SLOT 10	ON	ON	ON
SLOT 11	ON	ON	ON
SLOT 12	ON	ON	ON
SLOT 13	ON	ON	ON

SYSTEMS ENGINEERING ASSOCIATES, INC.
ARVADA, COLORADO



SCALE: _____ APPROVED: _____
DATE: 9-10-96

DRAWN BY: KDV
REVISED: 6/7/05

HSL-SM6X2
ELECTRICAL CONTROL SCHEMATIC

SYSTEMS ELECTRONICS GROUP

WO# _____
PT# _____
DRAWING NUMBER 14-4629-10

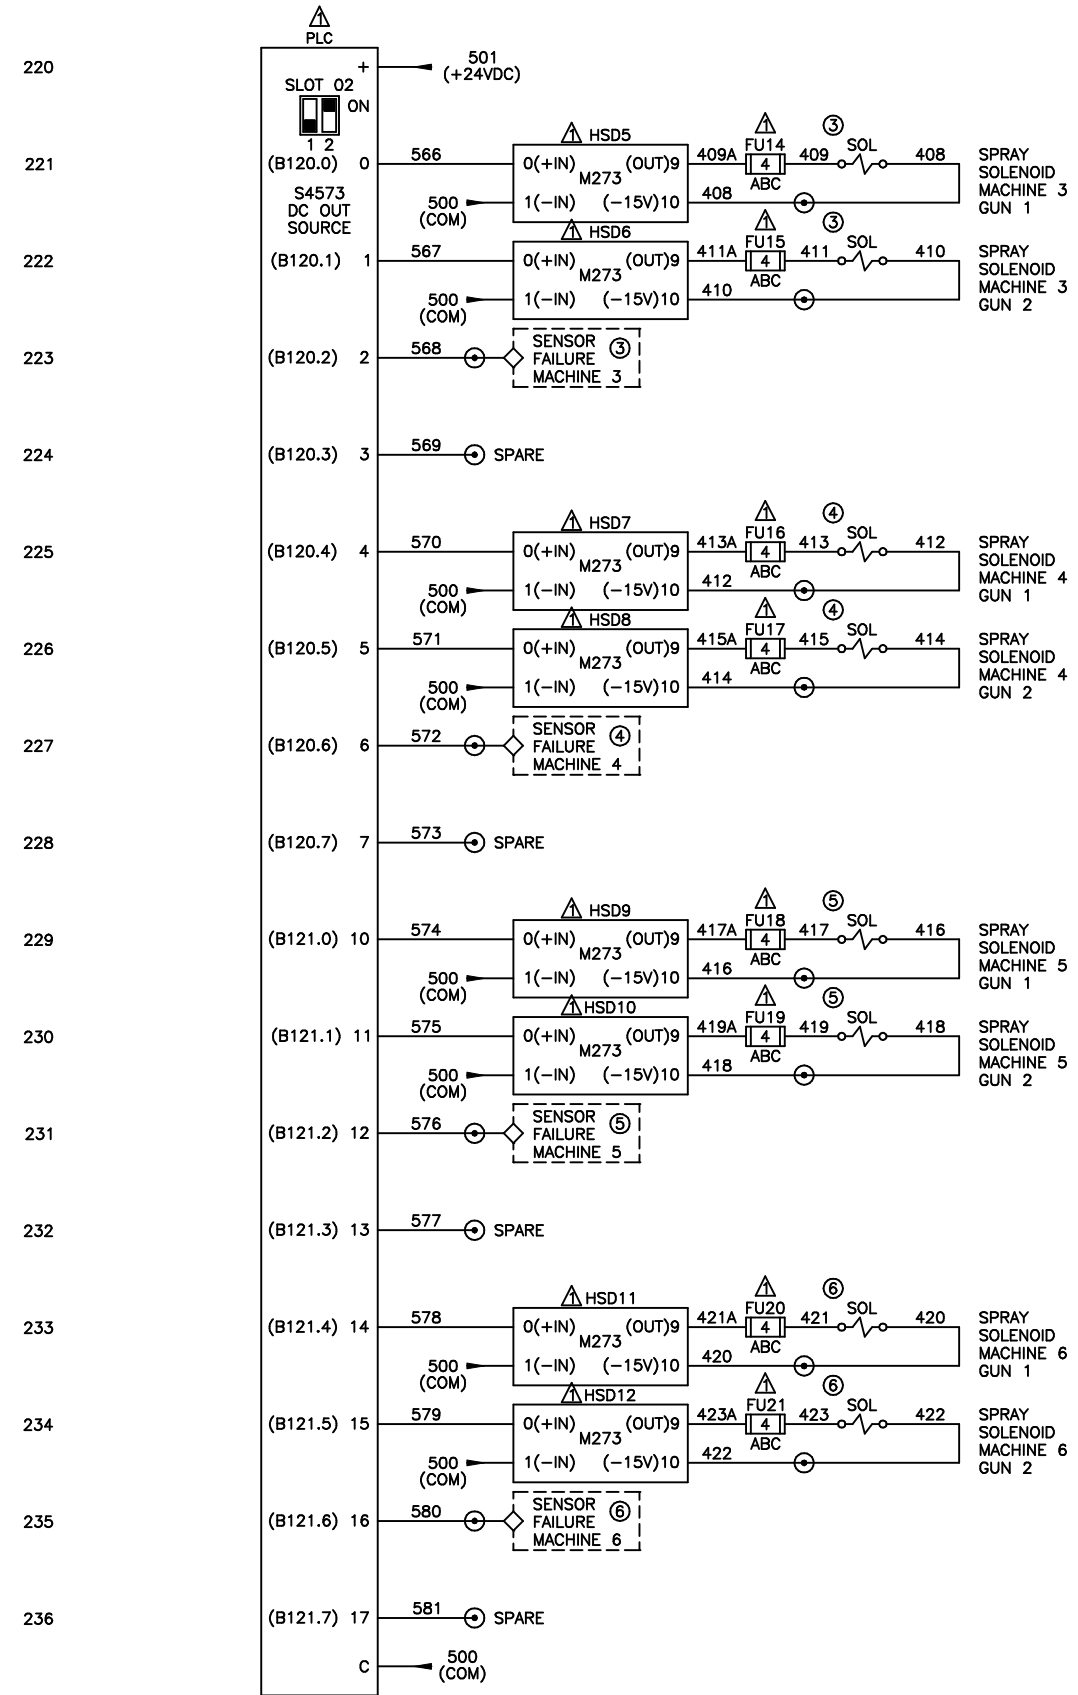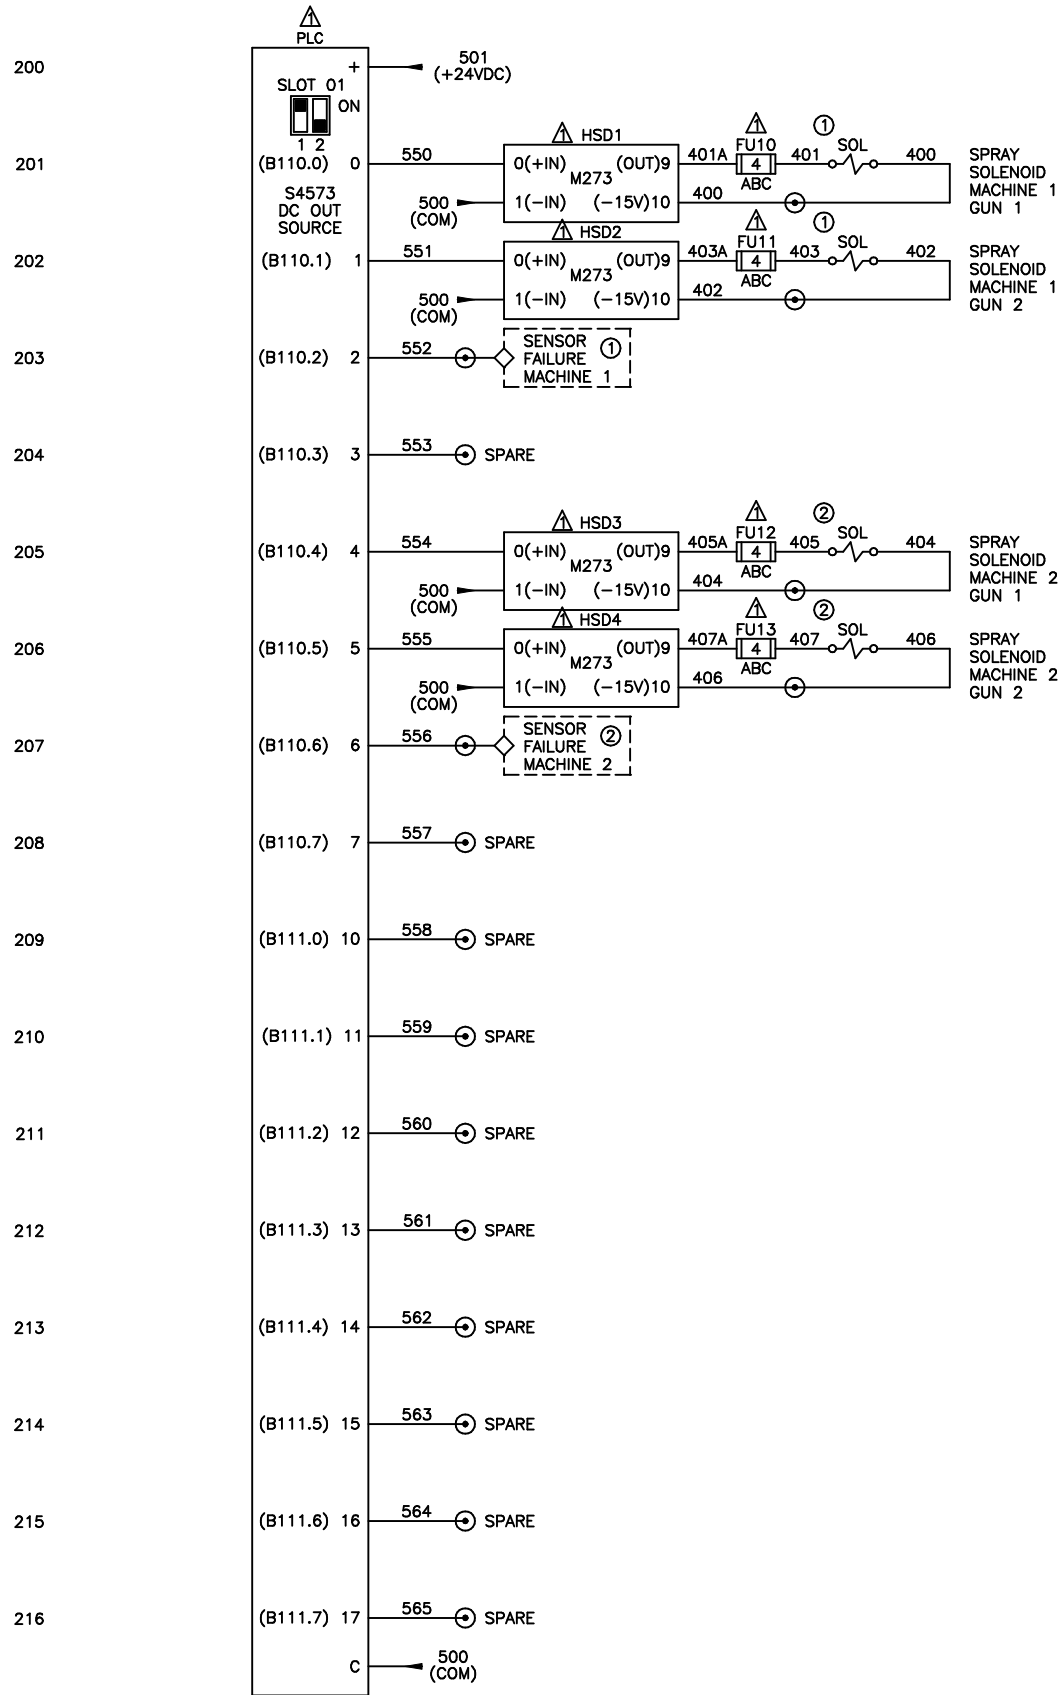

CONFIDENTIAL This document is the property of Systems Engineering Assoc., Inc. The information contained herein is confidential and is not to be reproduced, copied or disclosed to others. Drawing to be returned upon request.	SYSTEMS ENGINEERING ASSOCIATES, INC. ARVADA, COLORADO		
	SCALE:	APPROVED:	DRAWN BY: KDV
	DATE: 9-10-96		REVISED: 6-7-05
	HSL-SM6X2 ELECTRICAL CONTROL SCHEMATIC		WO#
	SYSTEMS ELECTRONICS GROUP		PT# DRAWING NUMBER 14-4629-10